


Schedule			
Symbol	Discription	Symbol	Discription
	Single PowerPoint		Step Lights
	Double PowerPoint		Data Point
	Heated Towel Rail		Extract Fan
	Main Switchboard		Wall Light
	Ceiling Light		Sensor light
	Three In One		Alarm Sensor
	Switch		Alarm Keypad
	Pandent Light		Outdoor Buzzer
	PIR Sensor		Indoor Buzzer

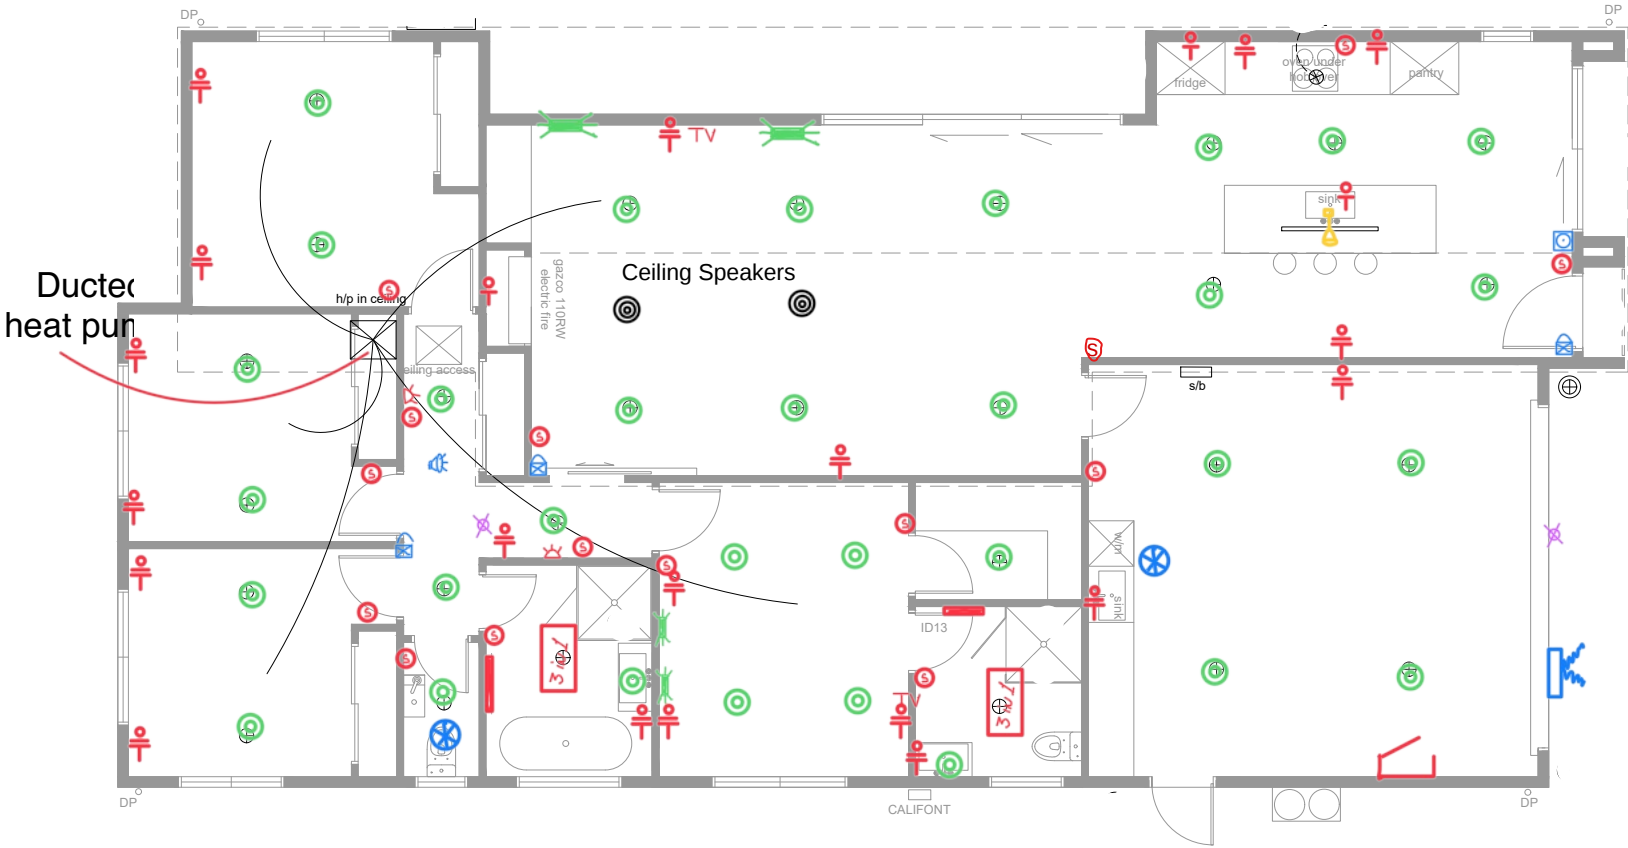

REVISION:	DATE:	JOB NAME:	STATUS:	DATE:
		LOT 392 WOONG TREE	CONSENT	04.06.24
		DRAWING NAME:	JOB NO:	DWG NO:
		ELECTRICAL PLAN	2407	A4.00